



- FIRE SAFETY SIGNAGE AND FIRE FIGHTING EQUIPMENT ETC KEY**
- ▽ WATER SPRAY EXTINGUISHER 6 LITRE
 - ▽ CO2 EXTINGUISHER 2KG
 - FB SMALL FIRE BLANKET
 - FE FIRE EXIT SIGN ILLUMINATED
 - FE FIRE EXIT SIGN WITH DIRECTIONAL ARROW
 - PUSH BAR / PANIC BOLT DOOR RELEASE WITH RELEVANT SIGNAGE
 - KC FIRE EXIT KEEP CLEAR SIGN
 - LS FIRE DOOR KEEP LOCKED SHUT SIGN
 - DENOTES HALF HOUR FD30S DOOR, WITH CLOSER
 - DENOTES HALF HOUR FD30S DOOR, LOCKED SHUT
 - DENOTES ONE HOUR FIRE DOOR, WITH CLOSER
 - DENOTES ONE HOUR FIRE DOOR, LOCKED SHUT
 - VP DENOTES VISION PANEL IN DOOR
 - EXTINGUISHER POINT / USAGE SIGNS TO BE PROVIDED WITH ALL EXTINGUISHERS

- FIRE ALARM SYSTEM KEY**
- FACP FIRE ALARM CONTROL PANEL
 - FARP FIRE ALARM REPEATER PANEL
 - AN FIRE ACTION NOTICE
 - MCP MANUAL CALL POINT WITH CALL POINT SIGN ABOVE
 - SD SMOKE DETECTOR (OPTICAL)
 - CS COMBINED SMOKE DETECTOR AND SOUNDER
 - CSX COMBINED SMOKE DETECTOR, SOUNDER AND BEACON
 - WAW FIRE ALARM WALL MOUNTED SOUNDER, BEACON
 - BA FIRE ALARM BEACON
 - HD HEAT DETECTOR
 - CSX COMBINED HEAT DETECTOR, SOUNDER AND BEACON
 - SDX SMOKE DETECTOR MOUNTED ABOVE CEILING LEVEL WITHIN CEILING VOID WITH REMOTE INDICATOR FLUSH MOUNTED INTO CEILING TILE BELOW
 - IU INTERFACE UNIT
 - SOUND (CEILING MOUNTED)
 - CSX COMBINED SOUNDER AND BEACON (CEILING MOUNTED)
 - AD AUTOMATIC DOOR HOLD OPEN/CLOSER
 - ASP ASPIRATOR SYSTEM AIR SAMPLING UNIT
 - ASP ASPIRATOR SYSTEM PIPE IN ROOF VOID
 - B DETECTOR BEAM IN ROOF VOID
 - R DETECTOR BEAM REFLECTOR IN ROOF VOID
 - BC DETECTOR BEAM CONTROLLER


- EMERGENCY LIGHTING KEY**
- FE FIRE EXIT SIGN ILLUMINATED
 - EL EMERGENCY LIGHT BATTEN FITTING
 - EL EMERGENCY LIGHT RECESSED FITTING
 - EL EMERGENCY LIGHT BULKHEAD TYPE FITTING
 - EL EMERGENCY LIGHT EXTERNAL FITTING OVER DOOR
 - EL EMERGENCY LIGHT LED RECESSED FITTING
 - EL EMERGENCY LIGHT EXTERNAL WALL FITTING

NOTE
LAYOUT AS SHOWN INDICATIVE ONLY AND SUBJECT TO FINAL DESIGN BY SPECIALISTS AND SETTING OUT ON SITE TO SUIT FINISHES ETC.

floor plan licence
1:100



PROJECT
Licence Plan
Elmswell Food Store
Ashfield Road
Elmswell IP30 9BS
for East of England Co-op.
SCALE 1:100onA2 DATE Oct. 2024
DRAWN CHKD/AUTHD.

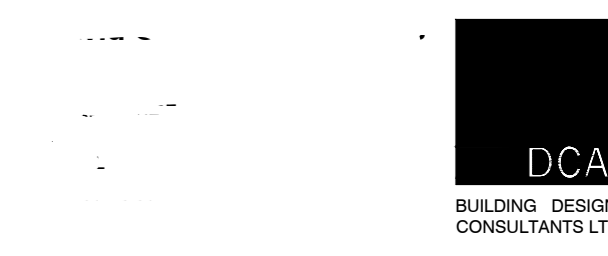

DRAWING NUMBER
5097-437-LP1
REVISION

© THIS DRAWING MUST NOT BE REPRODUCED IN WHOLE OR IN PART WITHOUT WRITTEN CONSENT. DO NOT SCALE FROM THIS DRAWING. ALL DIMENSIONS ARE TO BE CHECKED AND VERIFIED ON SITE AND ALL DISCREPANCIES REPORTED TO DAVID CLARKE AND ASSOCIATES PRIOR TO CONSTRUCTION WORK TAKING PLACE.